


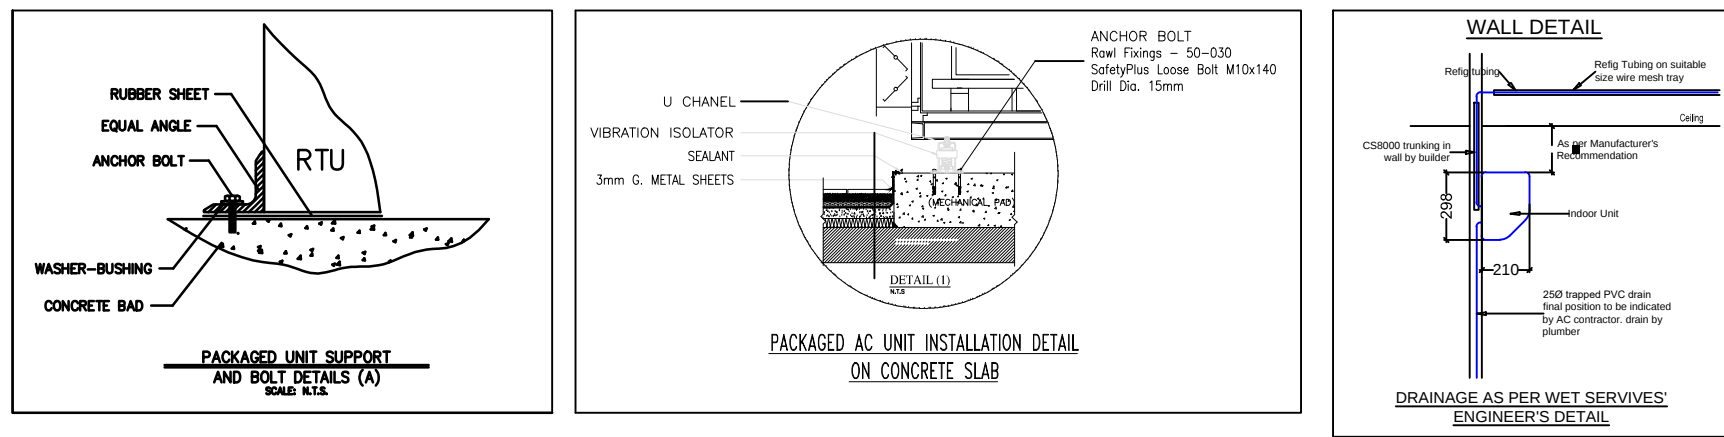

SCHEDULE OF EQUIPMENT		
NUMBER	DESCRIPTION	SIZE
SD1	SUPPLY DIFFUSER	600mm x 600mm Ø250mm CONNECTION
SD2	SUPPLY DIFFUSER	600mm x 600mm Ø200mm CONNECTION
RG1	RETURN GRILLE	600mm x 600mm

- LEGEND**

 - AC MIDWALL UNIT
 - EXTRACT FAN
 - EXTRACT AIR
 - FRESH AIR
 - SUPPLY AIR
 - RETURN AIR
 - SMOKE EXTRACT
 - 25mm CONDENSATE DRAINAGE

T1	13/05/2024	FOR TENDER
REV No	DATE:	DESCRIPTION:
REVISIONS SIZE ON ORIGINAL DRAWING 100 mm		

CLIENT

SABS
South African Bureau of Standards

PROJECT

NETFA MATERIALS
LABORATORY

DRAWING TITLE

HVAC LAYOUT

FILE No.			ITEM No.
DESIGN	T. MOYO	M. COLA	DRAWN
SCALE	1:100	T. MOYO	CHECKED
RESPONSIBLE PROFESSIONAL			
DATE	NAME & SURNAME	SIGNATURE	PR. NUMBER
13/05/2024	THABO MOYO		20120466

CAD SYSTEM:	AUTOCAD 2015	FILE NAME
SHEET SIZE	DRAWING NUMBER	REV
A1	SABS-NETFA-M6-01	T1