
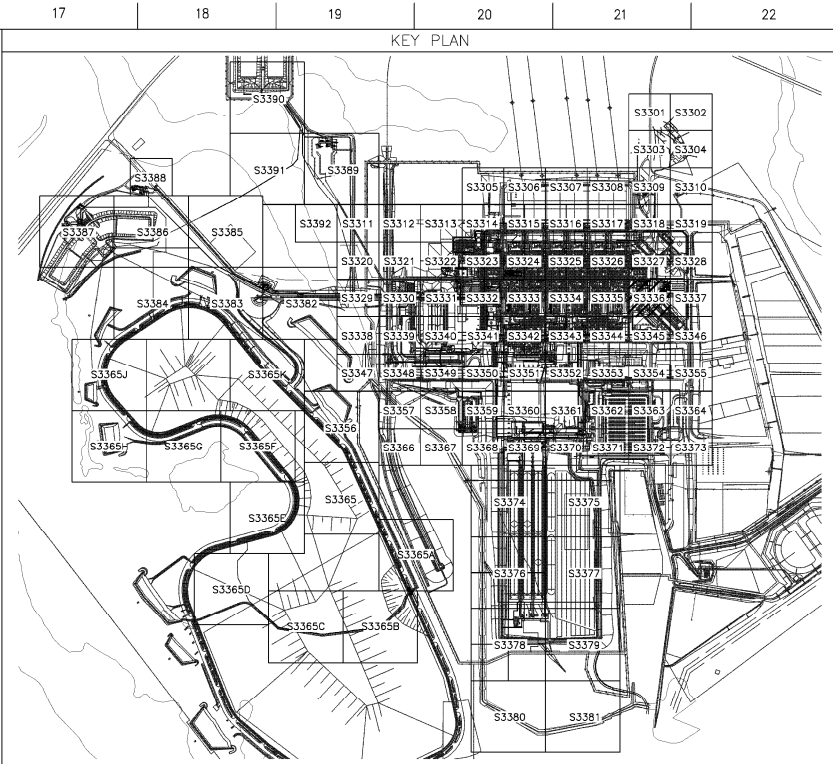


CS275893 AQ 18.2s (LUS Tech)
A18P017 1=1
01/16/16 08:35:51

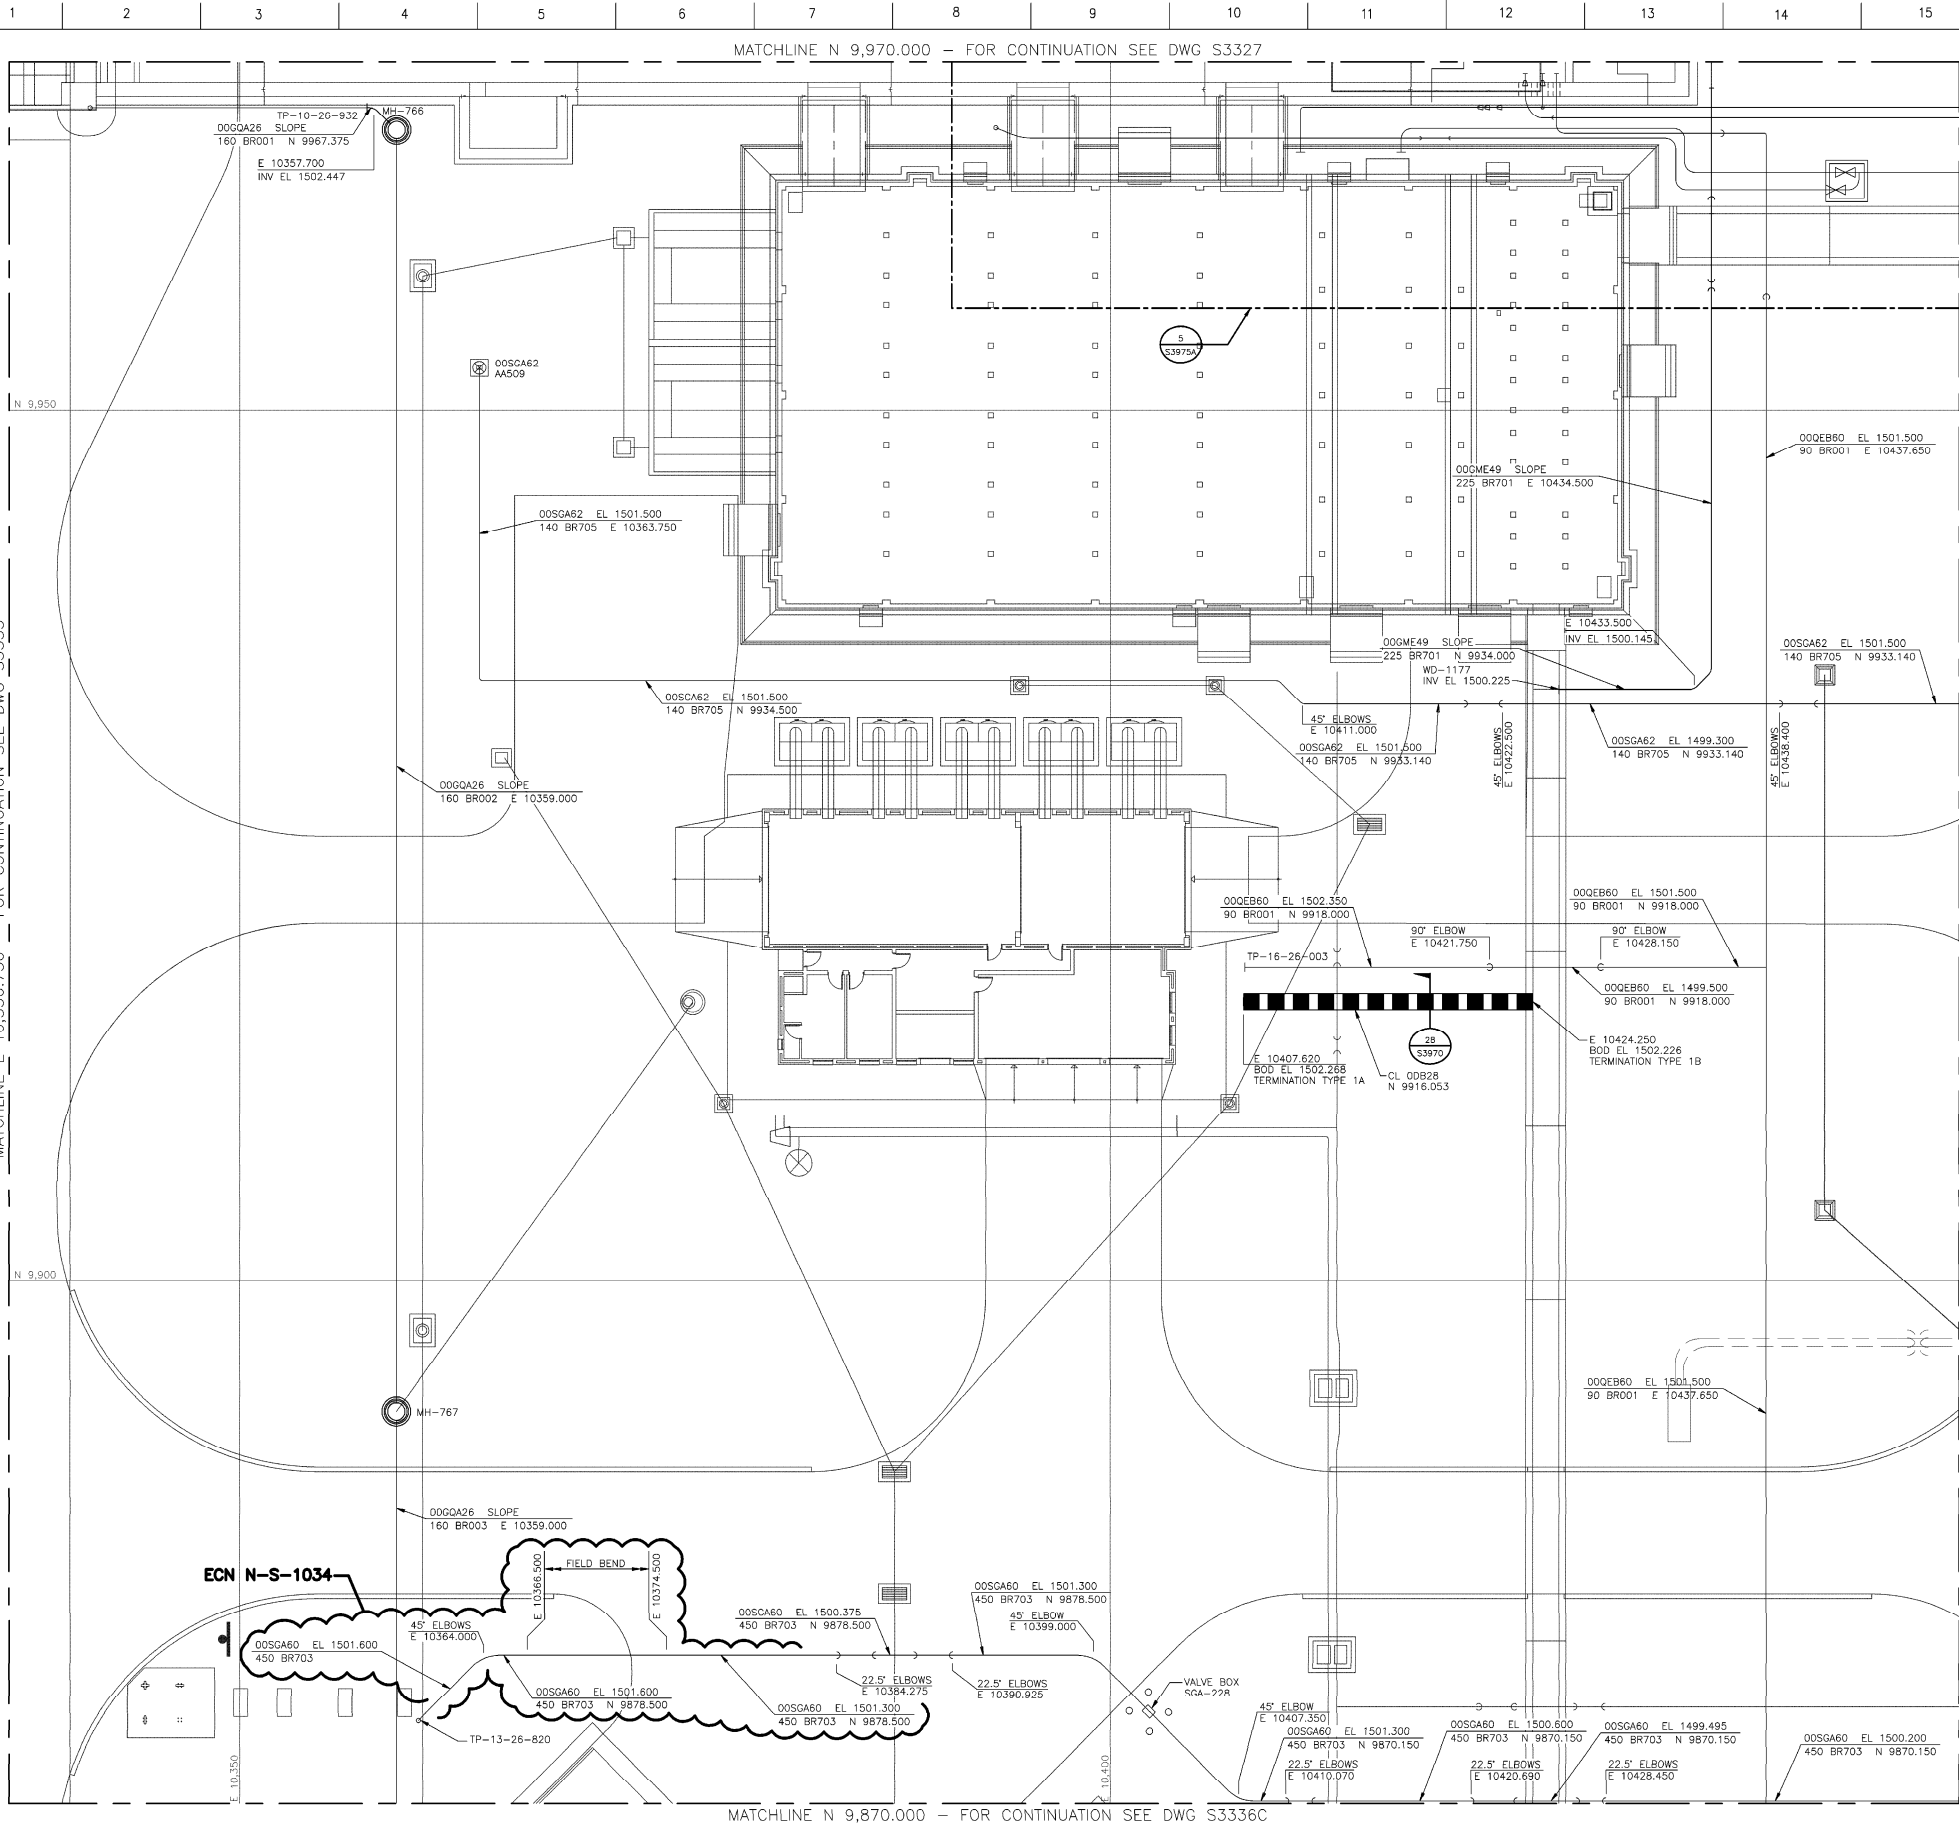


- NOTES
- SEE DWG S3300 FOR TERRACE UNDERGROUND FACILITIES KEY PLAN, GENERAL NOTES AND LEGEND.
 - SEE S3800 SERIES DRAWINGS FOR EXISTING SITE SERVICES UNDERGROUND UTILITY LOCATIONS AND INFORMATION.
 - SEE S3900 SERIES DRAWINGS FOR TERRACE UNDERGROUND FACILITIES SECTIONS AND DETAILS.

PIPE TERMINATION POINT (TP) LIST							
TP NO.	SYSTEM CODE (U/G)	SIZE (MM)	"X" FLANGE	LOCATION		FACE OF FLANGE EL.	TYPE
				NORTH	EAST		
10-26-932	GQA	160	PLAIN END	9967.375	10357.306	1502.451	H
13-26-820	SGA	355	PN 16 FF	9874.750	10360.250	1503.400	C1
16-26-003	QEB	90	PN 10 FF	9918.000	10407.700	1502.350	S

FLOOR DRAIN (FD) LIST						
FD NO.	SYSTEM CODE	OUTLET SIZE (MM)	LOCATION		TOP OF FD EL.	TYPE
			NORTH	EAST		
WD-1177	GME	200	9934.000	10425.750	1500.225	PP

APPROVED FOR CONSTRUCTION

 THE DISTRIBUTION AND USE OF THE NATIVE FORMAT CAD FILE OF THIS DRAWING IS UNCONTROLLED. THE USER SHALL VERIFY TRACEABILITY OF THIS DRAWING TO THE LATEST CONTROLLED VERSION.



REVISIONS				REFERENCE DRAWINGS			
NO.	DATE	BY	CHKD	NO.	DATE	BY	CHKD
10	18/JUN/16	ECN N-S-1034	NJO	DMH	YAW	AJS	
9	04/JUN/16	ECN N-S-0975	DMH	CAF	YAW	AJS	
8	10/MAY/16	ECN N-S-0814	LJP	CAF	GLG	AJS	
7	02/APR/16	ECN N-S-0680	CAF	JRB	GLG	AJS	
6	01/FEB/16	ECN N-S-0461	JDA	BMH	GLG	AJS	
5	01/JAN/16	ECN N-S-0345	JDA	BMH	GLG	MDC	
4	06/DEC/15	ECN N-S-0280	BMH	ALM	GLG	MDC	
3	11/AUG/15	ECN N-S-0213	KAD	ALM	GLG	MDC	
2	04/JUN/15	ECN N-S-0189	ALM	MJS	GLG	MDC	
1	01/MAY/15	ECN N-S-0172	ALM	BMH	GLG	MDC	
0	01/JAN/15	ISSUED FOR CONSTRUCTION	ALM	MJS	GLG	MDC	
DESIGNED BY: JRB				CHECKED BY: NJO			
DRAWN BY: JRB				SCALE: 1:150			
DATE: 18/JUN/16				PROJECT: KUSILE POWER STATION			
SHEET: 10				TERRACE UNDERGROUND FACILITIES-SITE PLAN-AREA 36			
SCALE: 1:150				146838-0UXC-S3336A			
SCALE: 1:150				0.90/24977			