



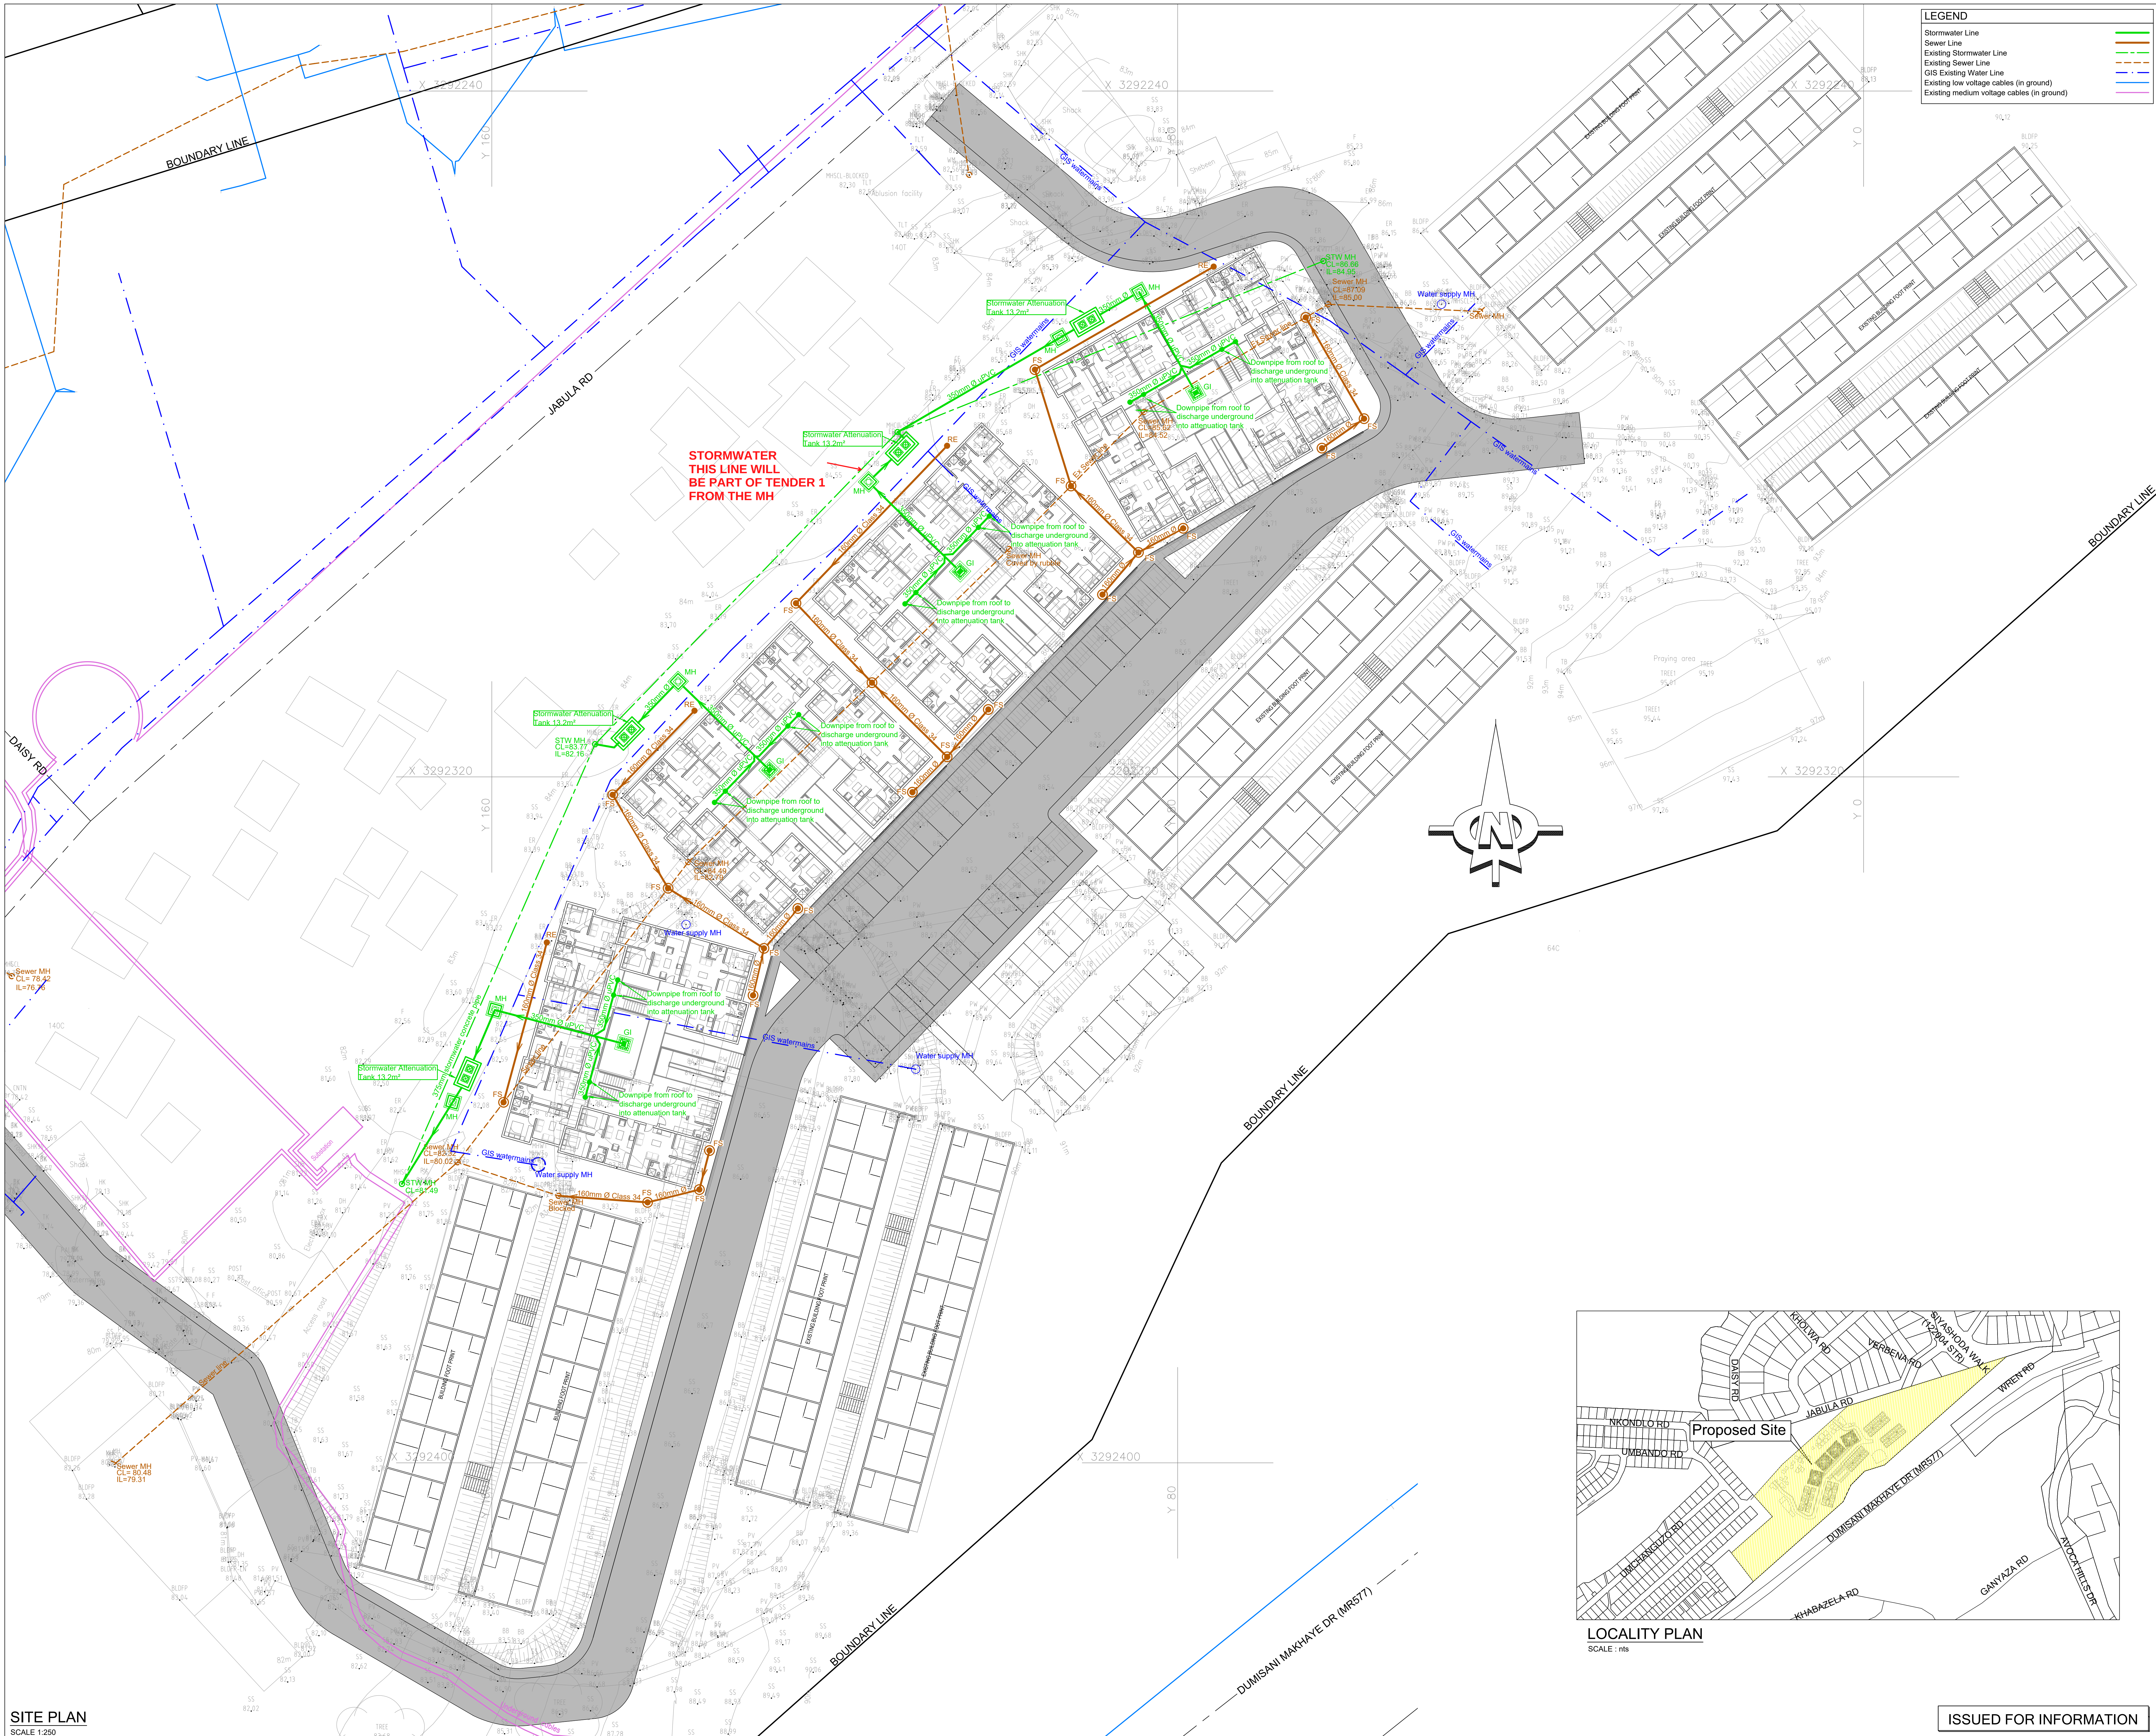

LEGEND

- Stormwater Line
- Sewer Line
- Existing Stormwater Line
- Existing Sewer Line
- GIS Existing Water Line
- Existing low voltage cables (in ground)
- Existing medium voltage cables (in ground)

- GENERAL NOTES**
- General
- These notes must be read in conjunction with the Specifications in the Bill of Materials. Where discrepancies arise the notes must take preference and such discrepancies must be drawn to the attention of the Engineer.
 - Drawings must be checked by the Contractor and any discrepancies in dimensions must be reported to the Engineer before work is commenced.
 - All drawings are to be read in conjunction with the Architect's drawings.
 - All work-providing to be to Architect's detail and instruction.
 - All work to be in accordance with the National Building Regulations.

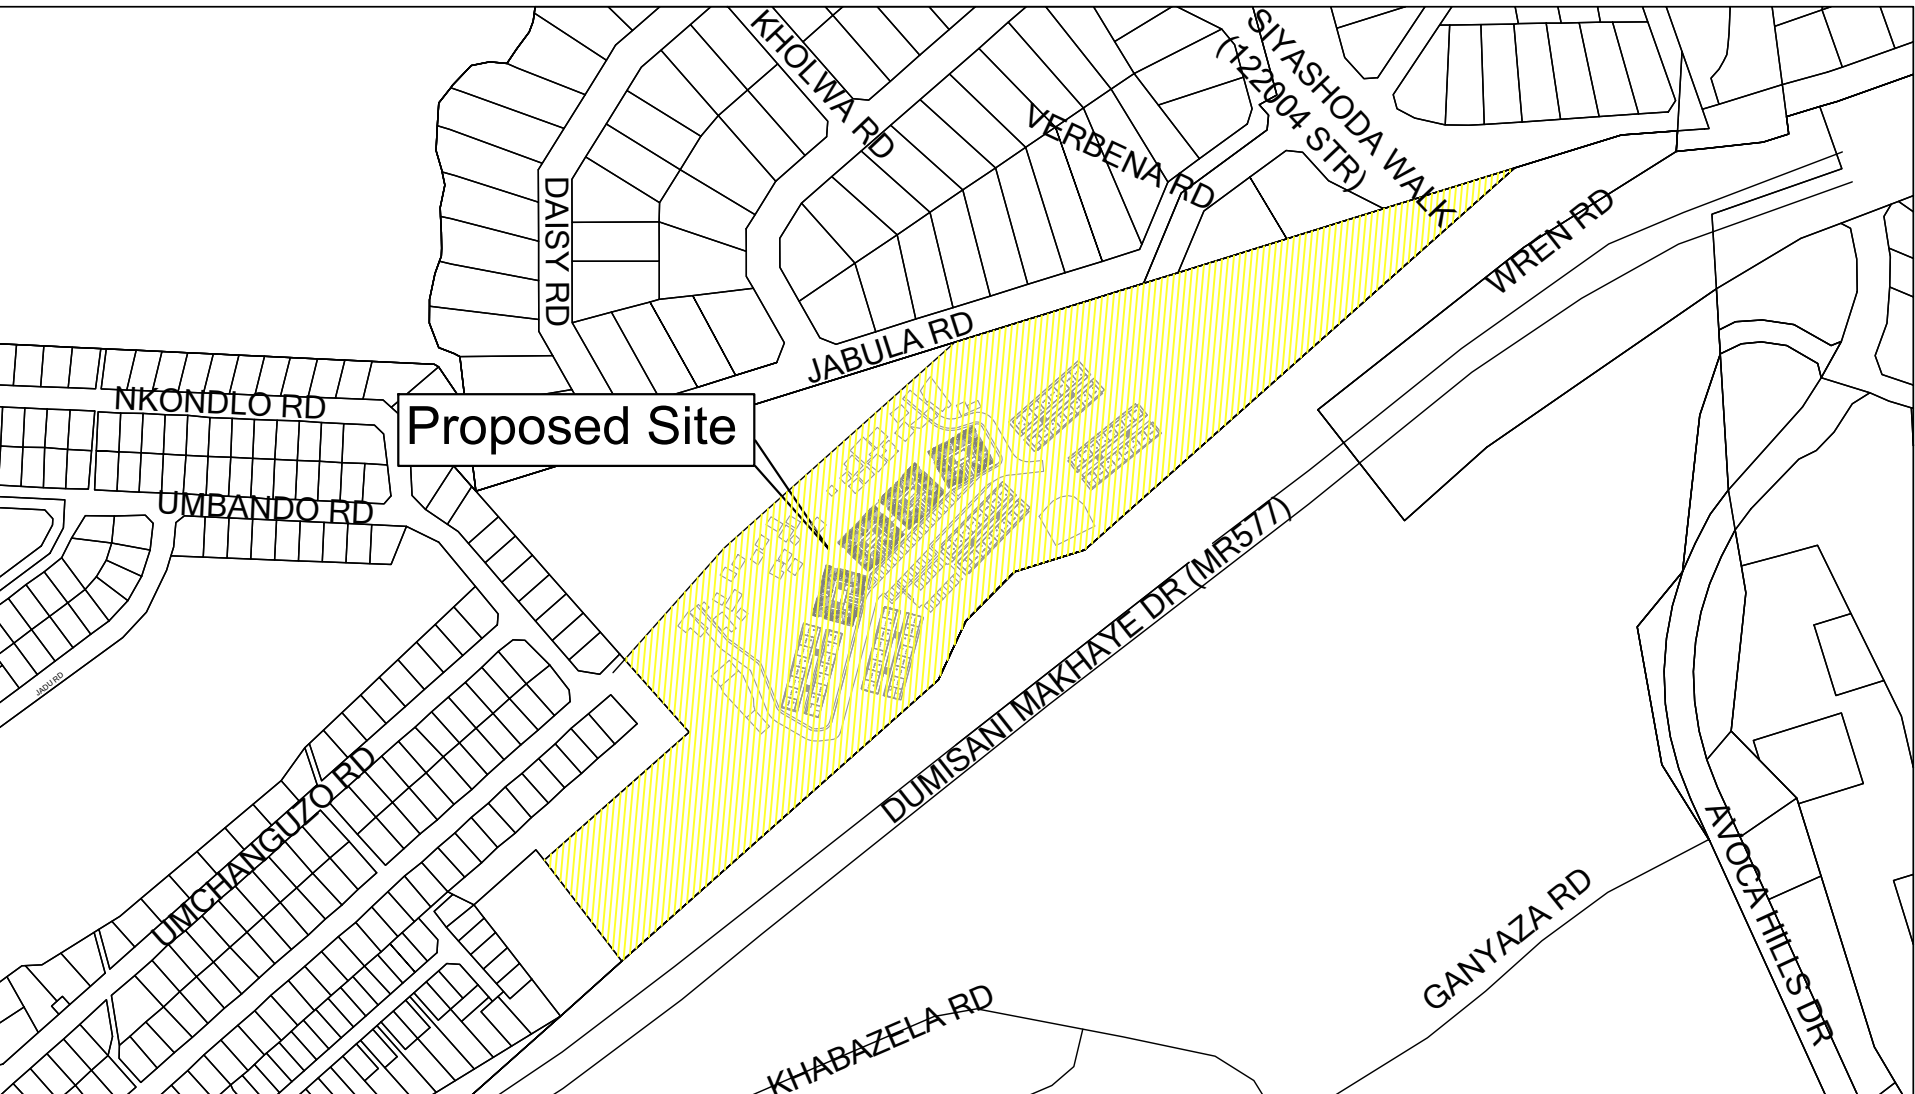

LOCALITY PLAN
SCALE: n/s

SITE PLAN
SCALE: 1:250

ISSUED FOR INFORMATION



human settlements
Department:
Human Settlements
PROVINCE OF KWAZULU-NATAL



P O BOX 22085
JENASHLEY
4022
TEL: 031-569 1310
EMAIL: econocom.co.za

ETHEKWINI MUNICIPALITY
The Design And Construction Monitoring Of
192 New Units At KwaMashu Community
Residential Units -Cru
Contract No. 1H-46254

STORMWATER AND SEWER LAYOUT

Drawn:	Checked:
Date:	Date:
Engineer:	Scale: 1:250
Drawing Number:	Revision:

2101-CE-02
A