



2800			
35	2270	20	440
2100			
	MUNICIPAL INFRASTRUCTURE GRANT		
	REPLACEMENT OF ASBESTOS PIPE AND RETICULATION AT MAKOMETSANE		
	CONTRACT No: JSMW-20/20-21/W19		
	IMPLEMENTING AGENT: DR JS MOROKA LOCAL MUNICIPALITY		
	TEL: 013 973 1101		
	FAX: 013 973 0974		
	CONSULTANTS'S NAME: MAHLANGU-BEHR & ASSOCIATES INFRASTRUCTURE		
	27 Aldrin Street, Reyno Manor, Emalaheni,1035		
	CONTRACTOR'S NAME:		
	(CONTRACTOR'S DETAILS)		
			
35	2800		

ALL WELDING,RIVETING,FIXING AND PAINTING
TO BE APPROVED BY ENGINEER ON SITE
LETTERING TO BE CAPITALISED.

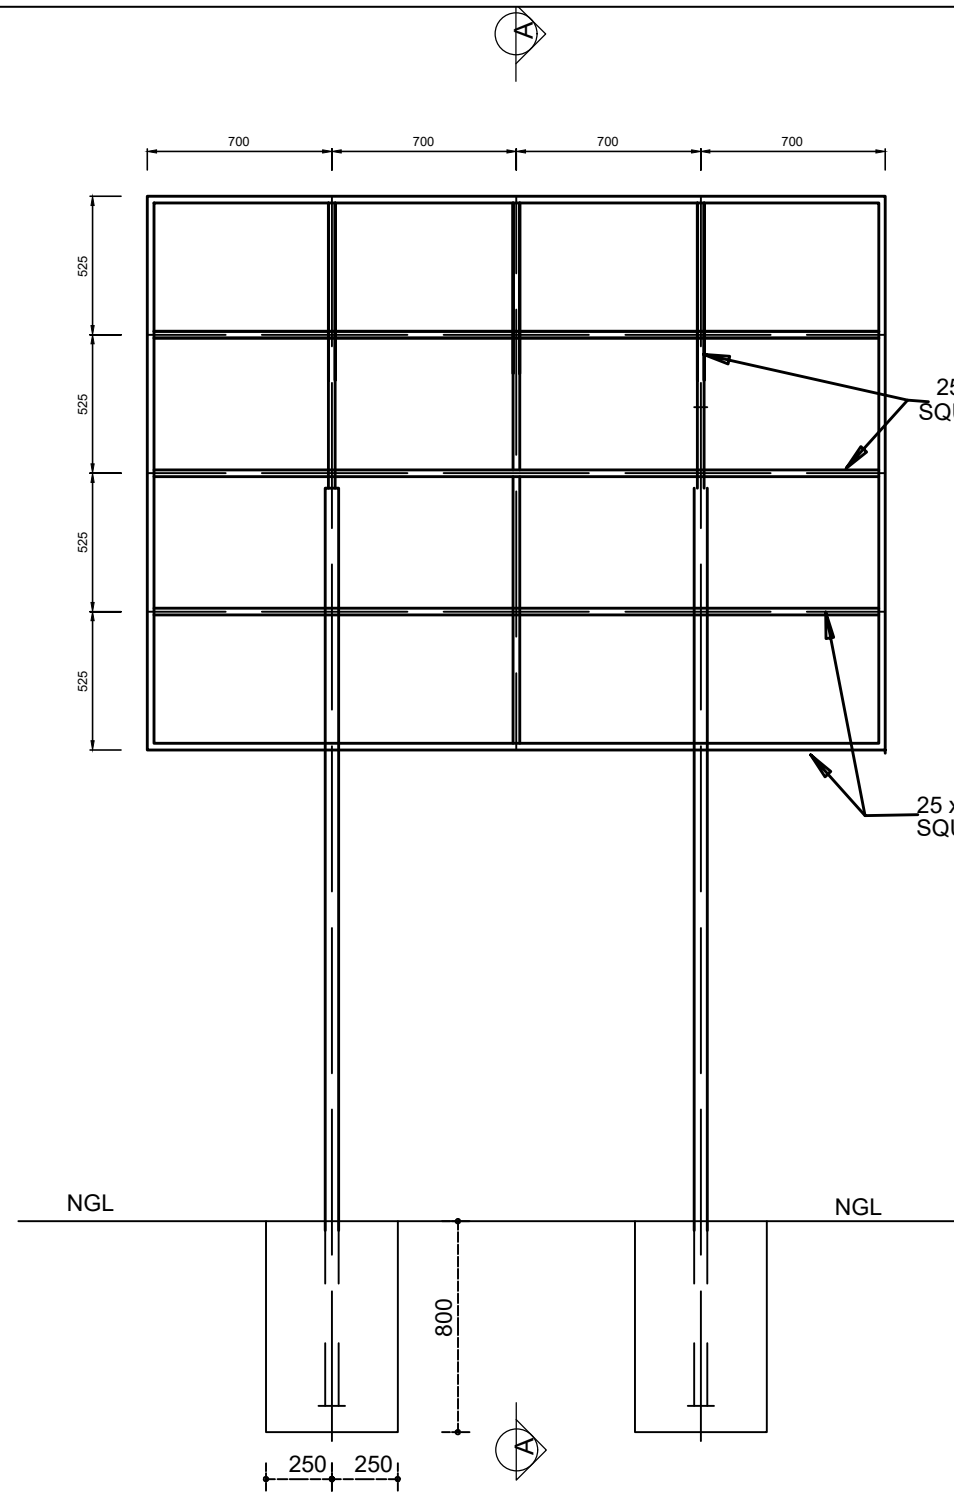

REAR ELEVATION

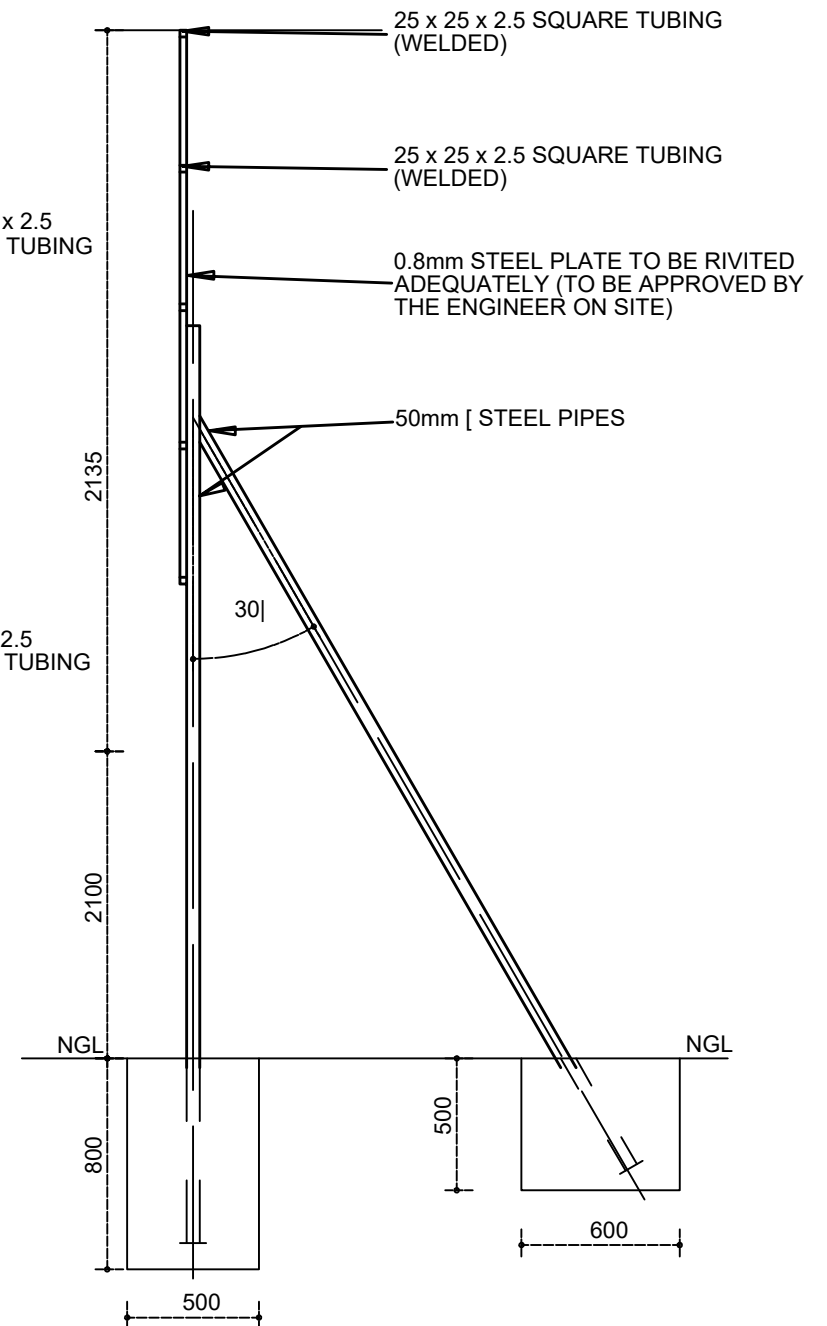

SECTION A-A

FOR TENDER				VERSION/AMENDMENTS				CONSULTING ENGINEERS:				PROJECT TITLE:				CLIENT:				SCALE:				SURVEYED:			
CONTRACT No.	DESCRIPTION	CERTIFIED BY	DATE	No.	DATE	DESCRIPTION	AUTHORISED BY	MAHLANGU – BEHR & ASSOCIATES INFRASTRUCTURE CONSULTANTS				PROJECT JSM W-20/20-21/W19 REPLACEMENT OF ASBESTOS PIPE AND RETICULATION AT MAKOMETSANE				Dr JS MOROKA LOCAL MUNICIPALITY				0 50 100				-			
								27 Adrin Street Reyno Manor Tel. 083 344 4448 Reyno Ridge Fax. 086 547 9210 WITBANK, 1035 Email. Mbainfraconsult@gmail.com				NAME BOARD								100mm ON ORIGINAL DRAWING				S.C.			
CERTIFIED CONSTRUCTION DRAWING FOR CONTRACTOR :																				ORIGINAL DRAWING SCALE: N.T.S. ORIGINAL DRAWING SHEET SIZE: A1				DESIGNED: N.B.			
ENGINEER				DATE																CO-ORDINATE SYSTEM: - DATE:				CHECKED: S.C.			
																				APPROVED:				APPROVED ON BEHALF OF ENG CONSULTING:			
																				CLIENT OR ASSIGNEE: DATE:				ENGINEER: DATE:			
																				CLIENT DRAWING No.: -				DRAWING No.: MBA-000/000			
																				CLIENT REF No.: -				VERSION: R0.1			