



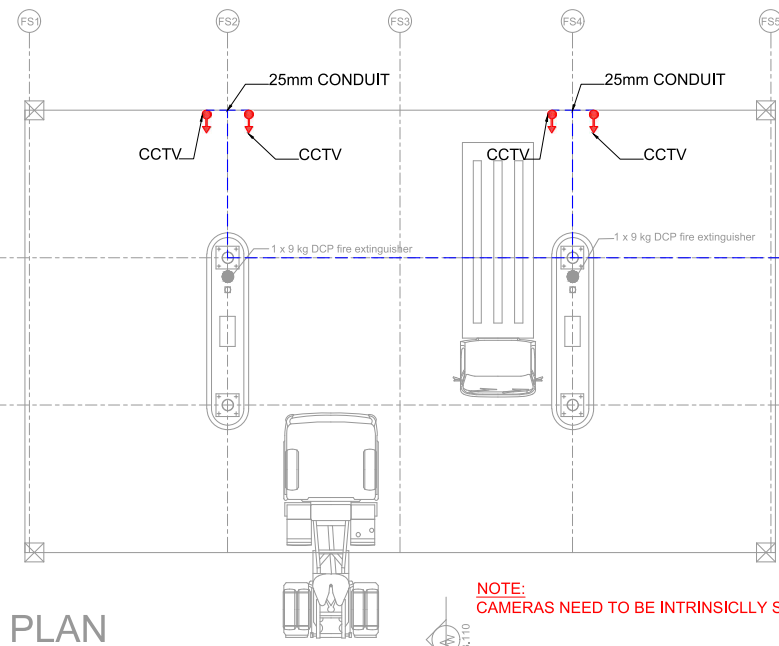

PLAN
FILLING STATION
Scale 1 : 100

NOTE:
CAMERAS NEED TO BE INTRINSICALLY SAFE

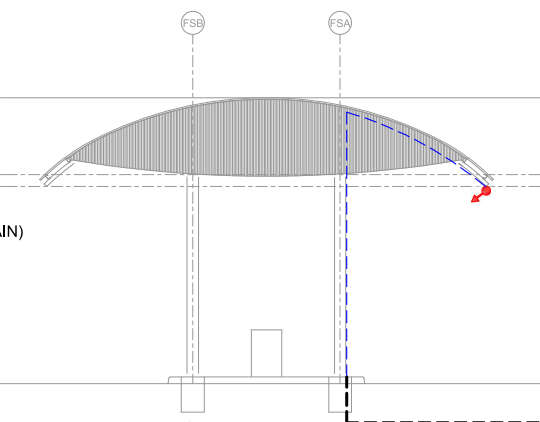

EAST ELEVATION
FILLING STATION
Scale 1 : 100

NOTES

THE CCTV SYSTEM DESIGNS ARE PROVIDED FOR INFORMATION AND NOT IMPLEMENTATION.

THE BUILDING CONTRACTOR SHALL PROVIDE THE FOLLOWING FOR THE CCTV SYSTEM.

- CONDUITS AND TRUNKING FOR THE ENTIRE CCTV SYSTEM AS REQUIRED BY THE DESIGN.

THE CBMS CONTRACTOR SHALL FURNISH AND INSTALL THE CCTV CAMERAS AND REQUIRED CCTV CABLING USING CONDUITS AND BOXES INSTALLED BY BUILDING CONTRACTOR.

LEGEND			
	CCTV (FIXED CAMERA)	4	
	P9000		
	25mm BOSAL		

DRAFT

0	2018.08.16	ISSUED FOR CONSTRUCTION		DM	BDL	PG			
B	2012.07.16	Drawing cancelled(No Access or CCTV required)		PH	BDL	PG			
A	2012.05.21	ISSUE FOR REVIEW		PH	BDL	PG			
D.O. REV		DATE	" REVISION "		REV BY	CHKD BY	AUTH BY	KKS APP	REFERENCE DRAWINGS
		INDEX REFERENCE :							
DRG REGISTR			AUTHORISED FOR ESKOM BY	DATE					
DESIGN APPROVED	2012.05.21	PG	S,MOODLEY	2011.08.11	KUSILE POWER STATION FILLING STATION 21415-S-FS-65.100				
KKS APP									
DO AUTH	2012.05.21	PH							
CHKD BY	2012.05.21	PH							
DRAWN BY	2012.05.21	PH			21415-S-FS-65.100				
SCALE		1:100		Eskom Enterprises					