


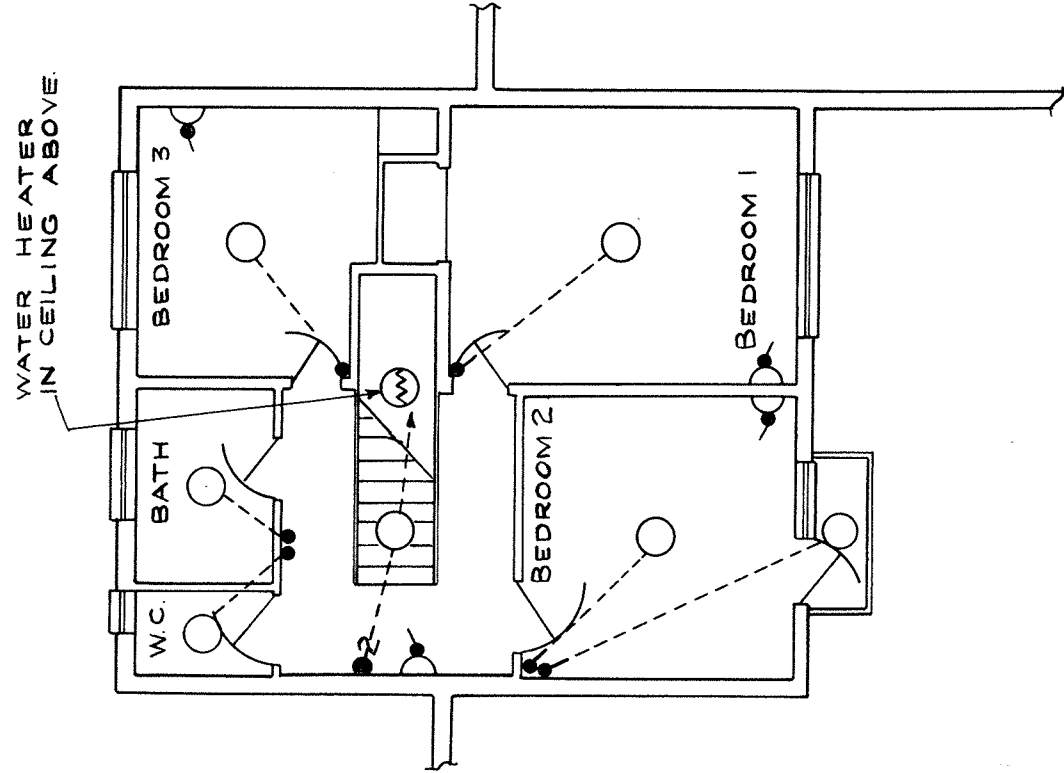


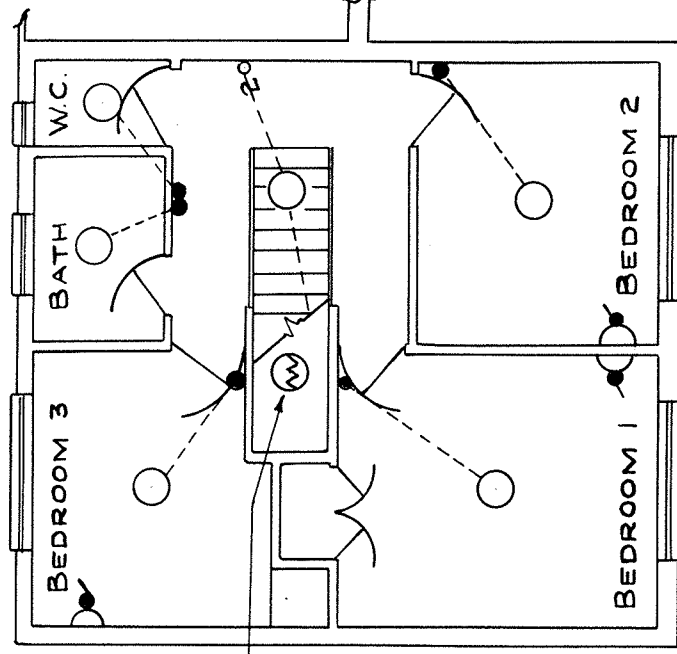

TYPE 'A' FIRST FLOOR PLAN

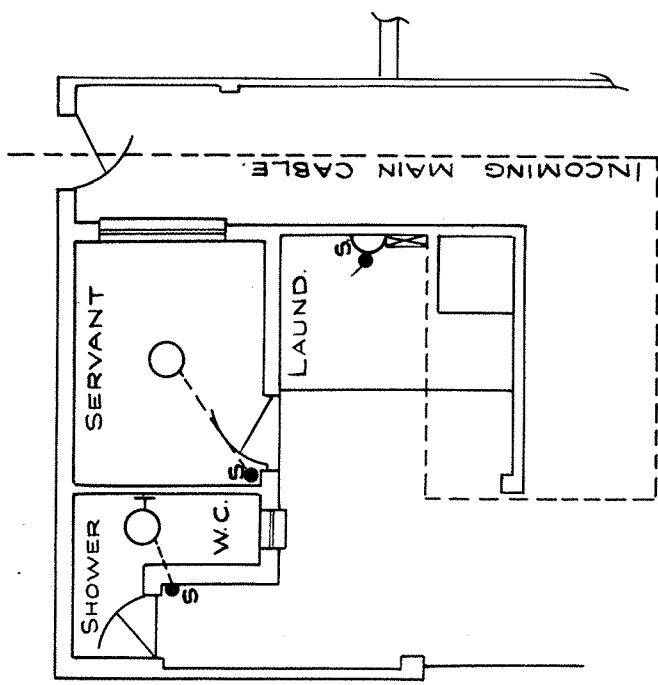


TYPE 'B' FIRST FLOOR PLAN

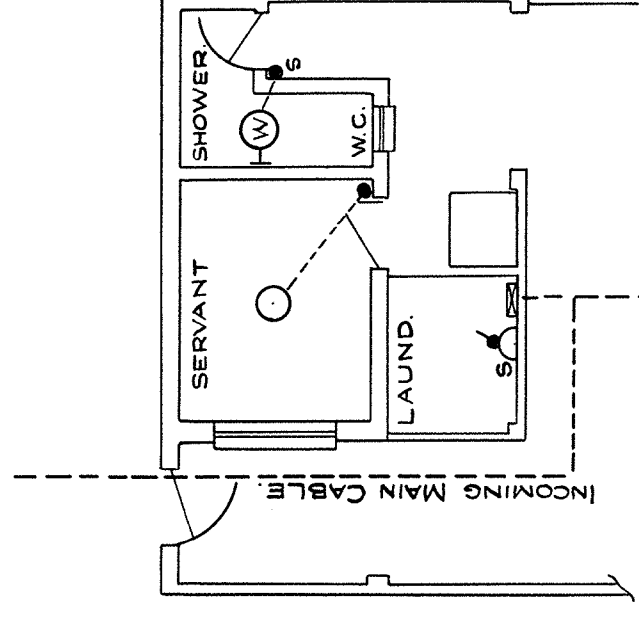

SYMBOL	ITEM
[Symbol]	FLUSH MOUNTED DISTRIBUTION BOARD
[Symbol]	" STOVE ISOLATOR
[Symbol]	" 15 AMP 3 PIN SWITCH SOCKET OUTLET
[Symbol]	" 5 AMP LIGHTING CONTROL SWITCH
[Symbol]	" 5 AMP 2-WAY LIGHTING CONTROL SWITCH
[Symbol]	" BELL PUSH BUTTON
[Symbol]	" TELEPHONE OUTLET (3" DIA. CONDUIT BOX)
[Symbol]	" SPACE HEATER
[Symbol]	SURFACE MOUNTED SPLITTER SWITCH
[Symbol]	" 15 AMP 3 PIN SWITCH SOCKET OUTLET(INDUST)
[Symbol]	" WEATHER-PROOFED LIGHTING CONTROL SW.
[Symbol]	WALL MOUNTED LIGHTING FITTING
[Symbol]	" " (WEATHER PROOFED)
[Symbol]	WATER HEATER (HORIZONTAL MOUNTED)
[Symbol]	CEILING MOUNTED LIGHTING FITTING
[Symbol]	6-VOLT BELL
[Symbol]	CABLE TO CONDUIT ADAPTOR BOX


LEGEND

1" CONDUIT TO DISTRIBUTION BOARD FOR INCOMING MAINS AND 3/4" CONDUIT FOR OUTBUILDING SUPPLY

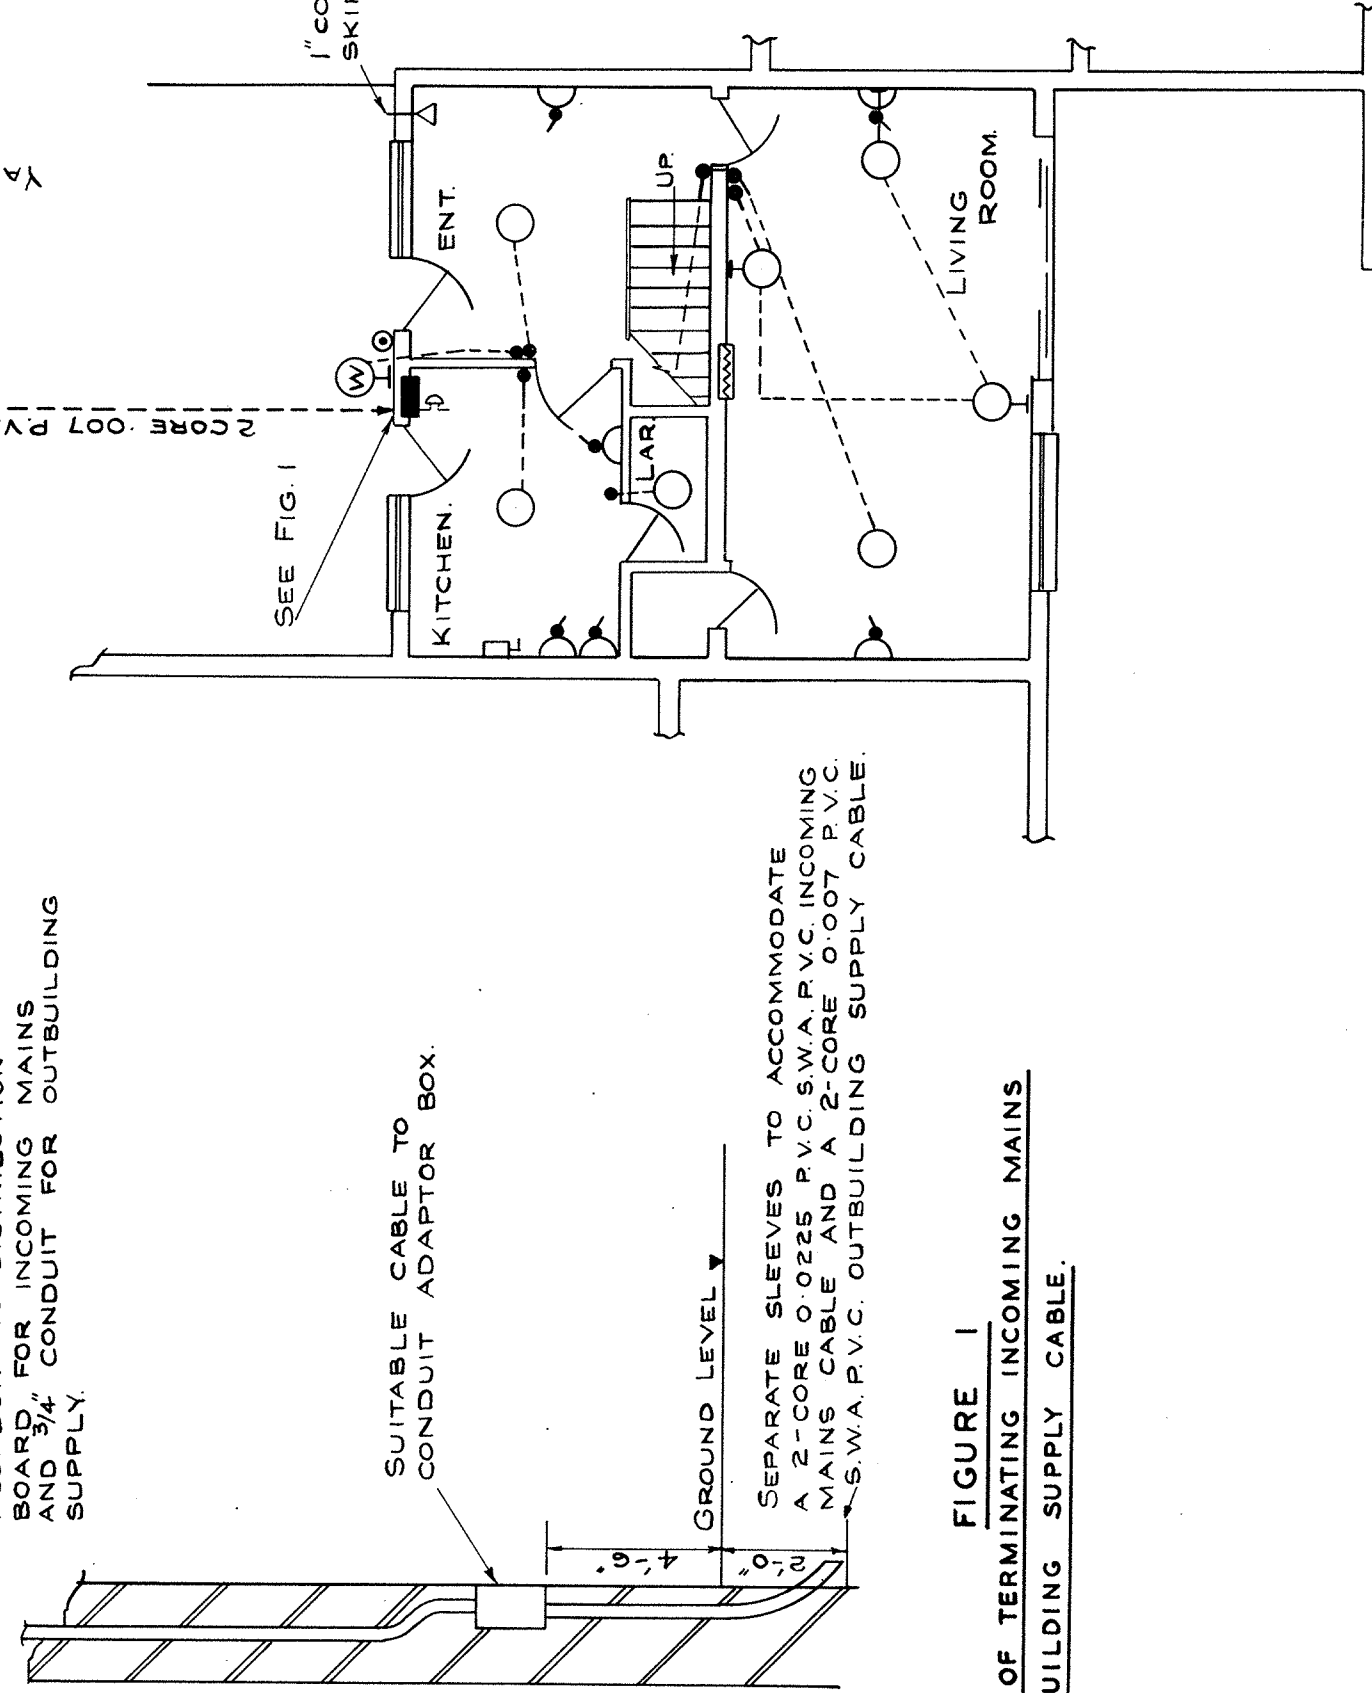

TYPE 'A' GROUND FLOOR PLAN

1" CONDUIT TELEPHONE OUTLET FROM ABOVE SKIRTING BOARD TO 2'-0" BELOW GROUND LEVEL

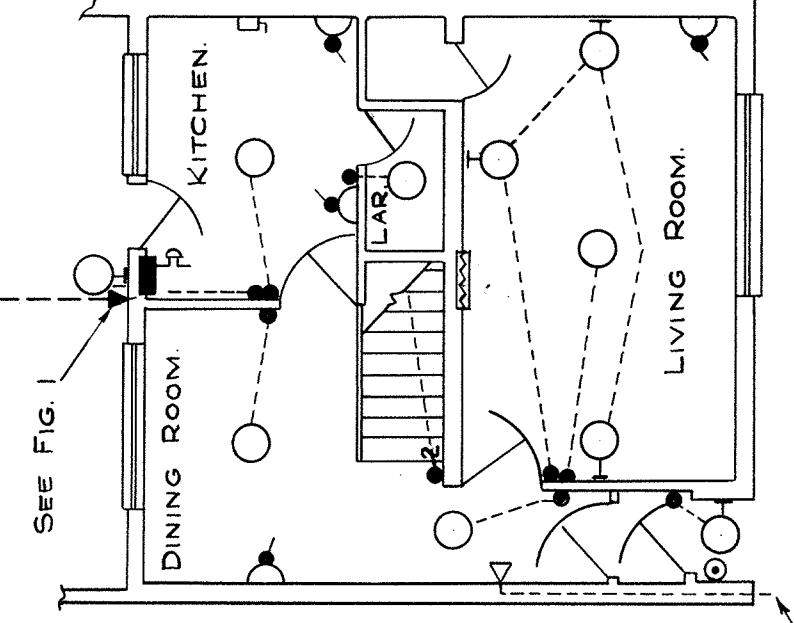

TYPE B GROUND FLOOR PLAN

YARD

FIGURE 1
METHOD OF TERMINATING INCOMING MAINS
OUTBUILDING SUPPLY CABLE

NOTE: FLATS TYPE BB ARE AS TYPE B, BUT MIRRORED.

RAND WATER BOARD.

ZUIKERBOSCH, ZWARTKOPJES & VEREENIGING PUMPING STATIONS

DUPLEX FLATS:
TYPE A & B.
ELECTRICAL INSTALLATION.
R.J. LABURN M.Sc (ENG.) (RAND)
A.M.I.C.E., M.A.S.C.E., M.(S.A.) I.C.E.
CHIEF ENGINEER.

DRG. No. A 2768

No.	DATE	CHECKED	APPROVED	REVISION	DRG. No.	REFERENCES	JOB No.	See DRG.	DATE: 2-8-1965
							W.O. No.	Nº 4752	DRAWN BY: M.J.M.
							CONT. NO.	1075	TRACED BY: D.D.
							SCHEME:	1965	CHECKED BY: A.S.S.
							SCALE:	1/8" = 1'-0"	APPROVED BY:

